


CONSTRUCTION NOTES AND ESTIMATED QUANTITIES

10A	INSTALL 8" P.V.C. WATER LINE WITH TRACER WIRE	158 L.F.
10B	INSTALL 6" P.V.C. WATER LINE WITH TRACER WIRE	24 L.F.
11	INSTALL 6" TEE	1 EA.
12	INSTALL 6" GATE VALVE	3 EA.
13	INSTALL 6" 45° BEND	1 EA.
14	INSTALL FIRE HYDRANT	1 EA.
15	INSTALL SPLASH PAD FOR FIRE HYDRANT	1 EA.
16	INSTALL CATHODIC PROTECTION/TRACER WIRE TEST STATION	1 EA.
17	INSTALL WATER SERVICE WITH CURB STOP	4 EA.
18	INSTALL 8"x6" REDUCER	2 EA.


NOTES:

1. EXISTING SERVICE TO BE ABANDONED AT CORPORATION STOP
2. DO NOT REUSE EXISTING 6" GATE VALVE

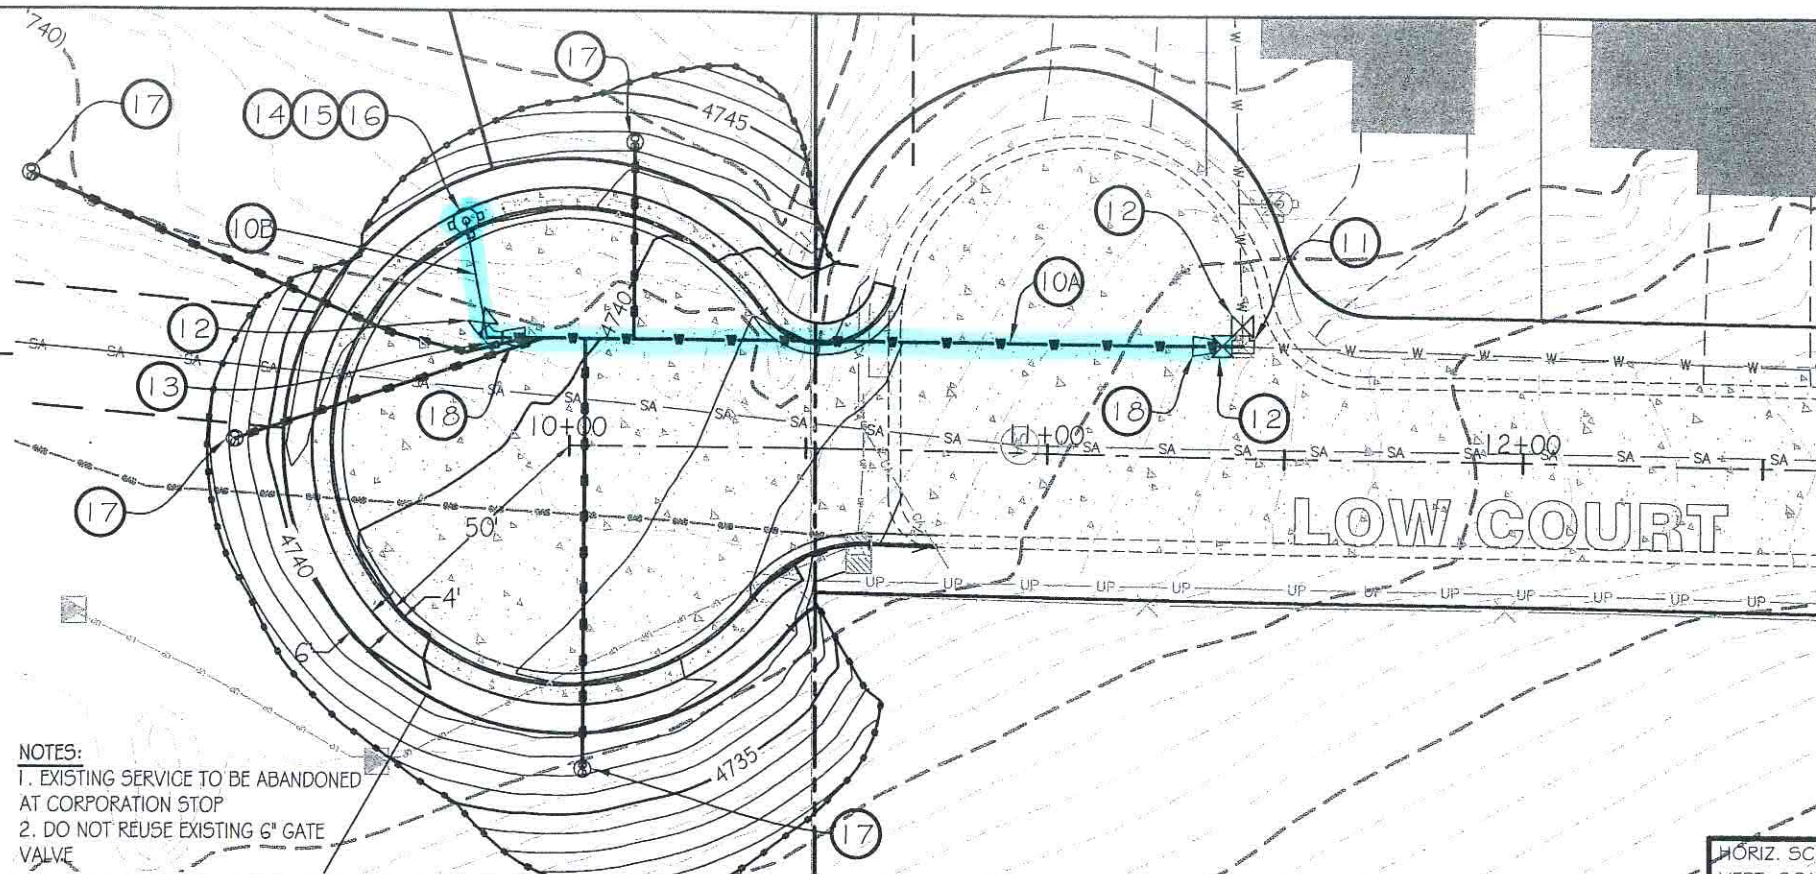

HORIZ. SCALE: 1"=40'
VERT. SCALE: 1"=4'

**FINAL RECORD
DRAWINGS**

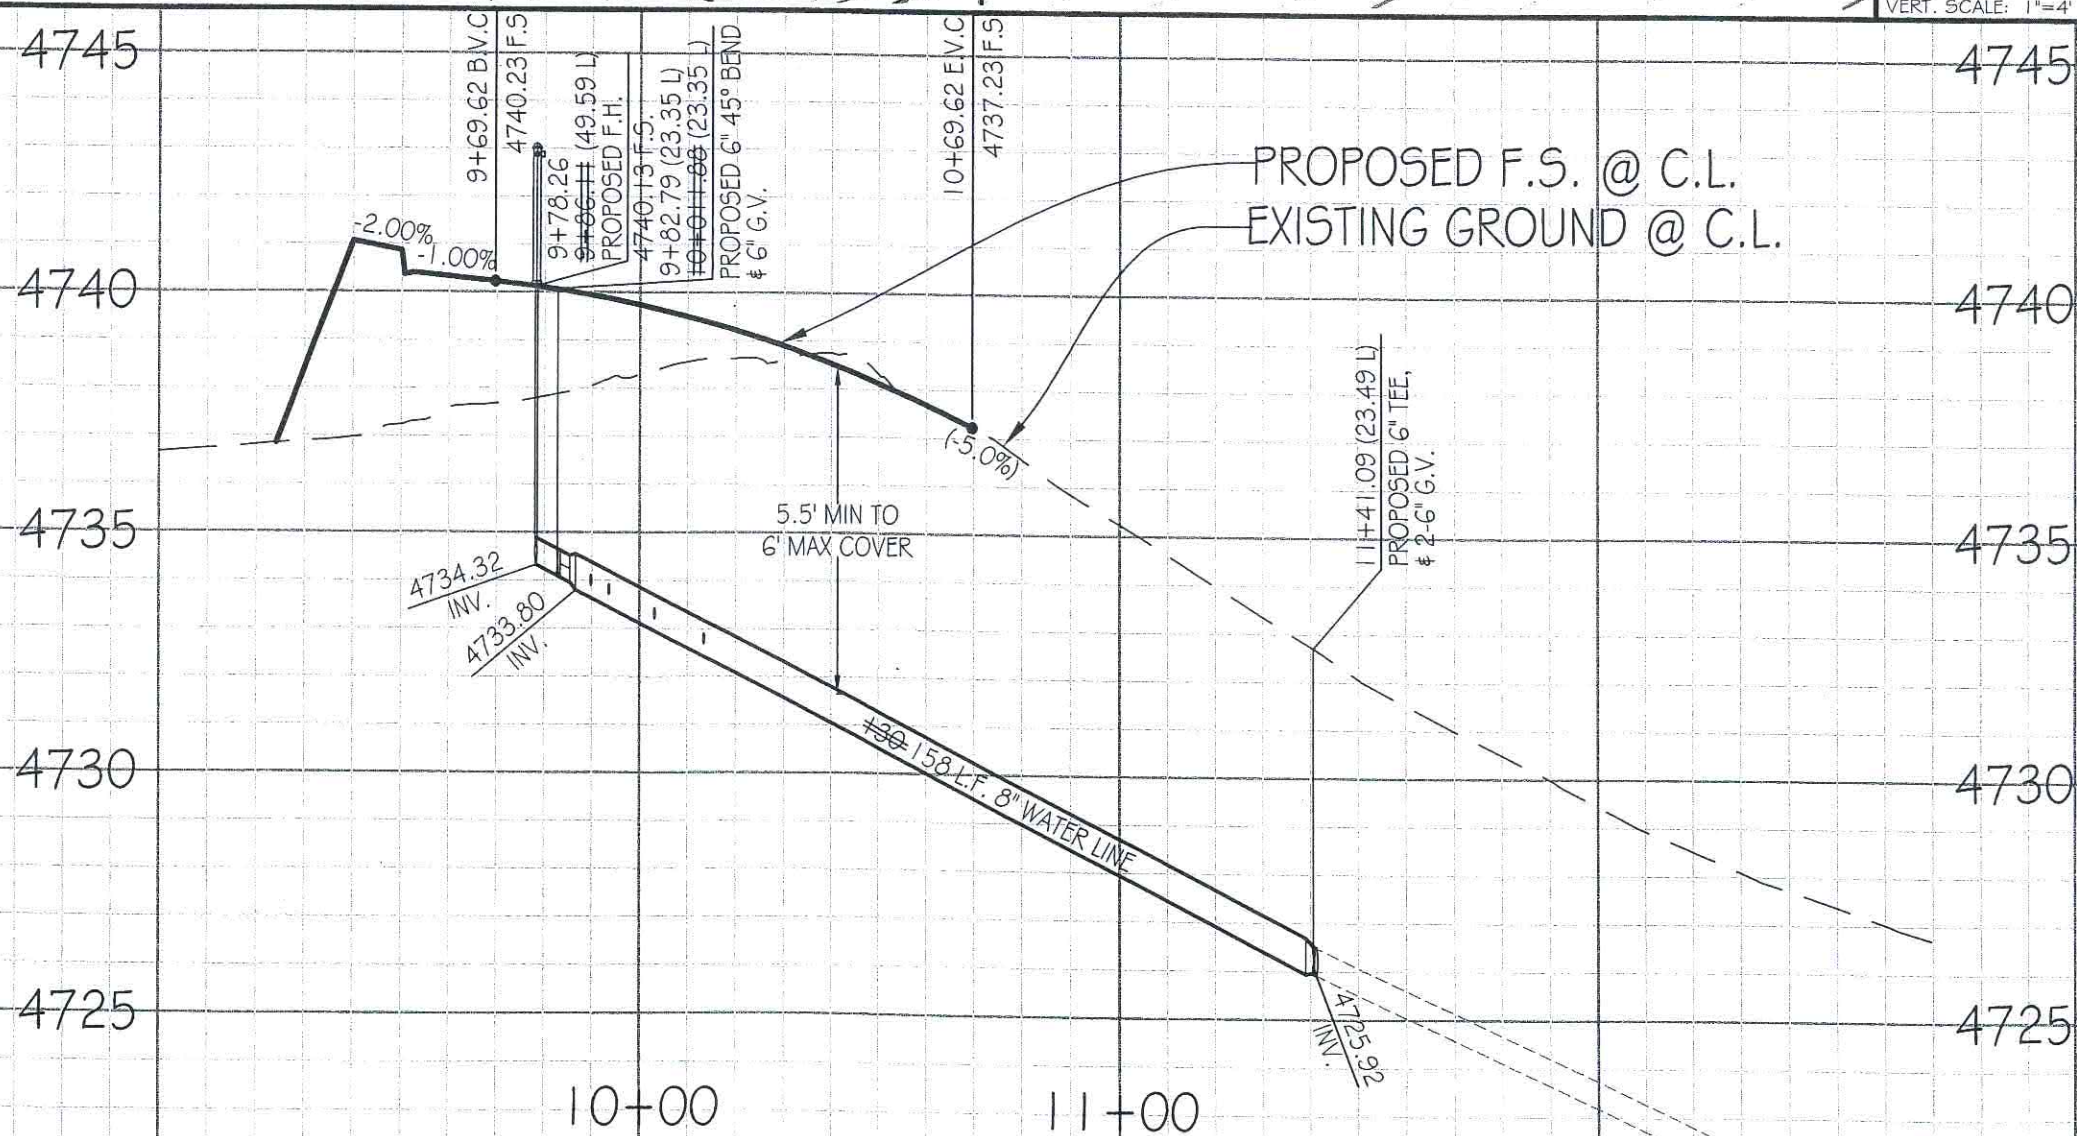

WESTOVER HILLS PHASE IV IMPROVEMENT PLANS LOW COURT WATER MAIN PLAN AND PROFILE

CAROL CHADWICK, P.E.
Civil Engineer
4300 Lexington Avenue
Gillette, WY 82718
(307) 680-1772
ccp@ccn.com

WYOMING • MONTANA • NEVADA • IDAHO • TEXAS
OREGON • CALIFORNIA • OKLAHOMA • N.C.E.S.

DATE: 10/07/19
JOB NO: 1213
DRAWN BY: CC
APPROVED BY: CC

WATER MAIN P&P
WA-1