
 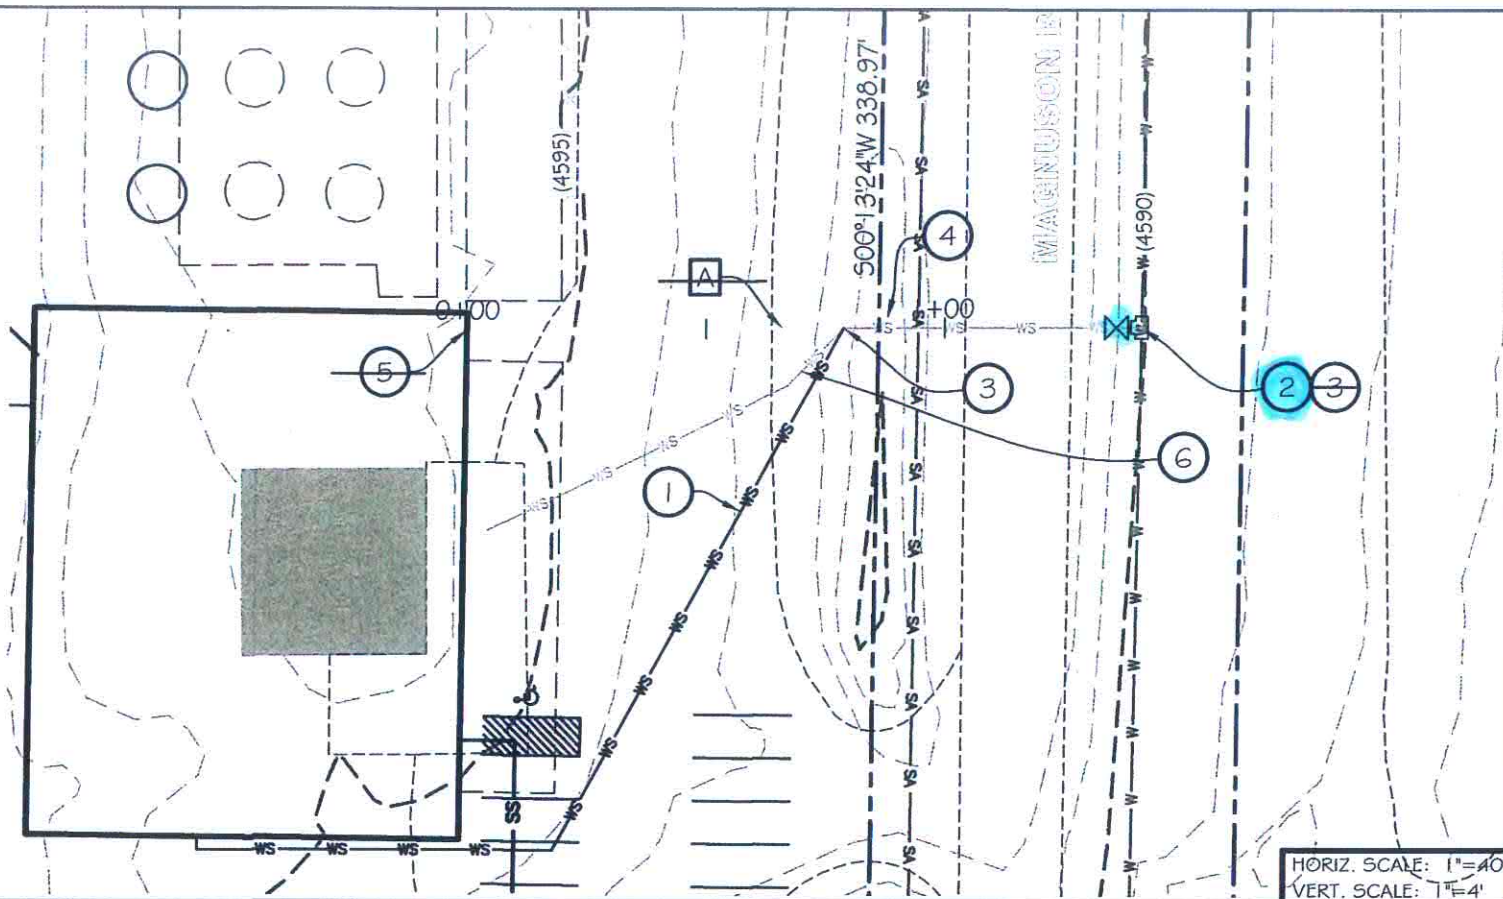


CONSTRUCTION NOTES AND ESTIMATED QUANTITIES


- 1. INSTALL 4" P.V.C. WATER SERVICE LINE 200 L.F.
- 2. INSTALL 4" GATE VALVE WITH CONCRETE COLLAR 1 EA.
- 3. INSTALL 8"x4"x8" TEE- CONNECT TO EXISTING 4" WATER LINE 1 EA.
- 4. INSTALL 2" THICK INSULATION BOARD 32 S.F.
- 5. CONNECT TO BLDG PER PLUMBING PLANS 1 EA.
- 6. REMOVE AND PLUG EXISTING TAP, WATER SERVICE & APPURTENANCES 1 EA.

| TANGENT DATA |         |
|--------------|---------|
| BEARING      | L, FEET |
| N89°40'43"E  | 140.99  |



HORIZ. SCALE: 1"=40'  
VERT. SCALE: 1"=4'

**FINAL RECORD  
DRAWINGS**

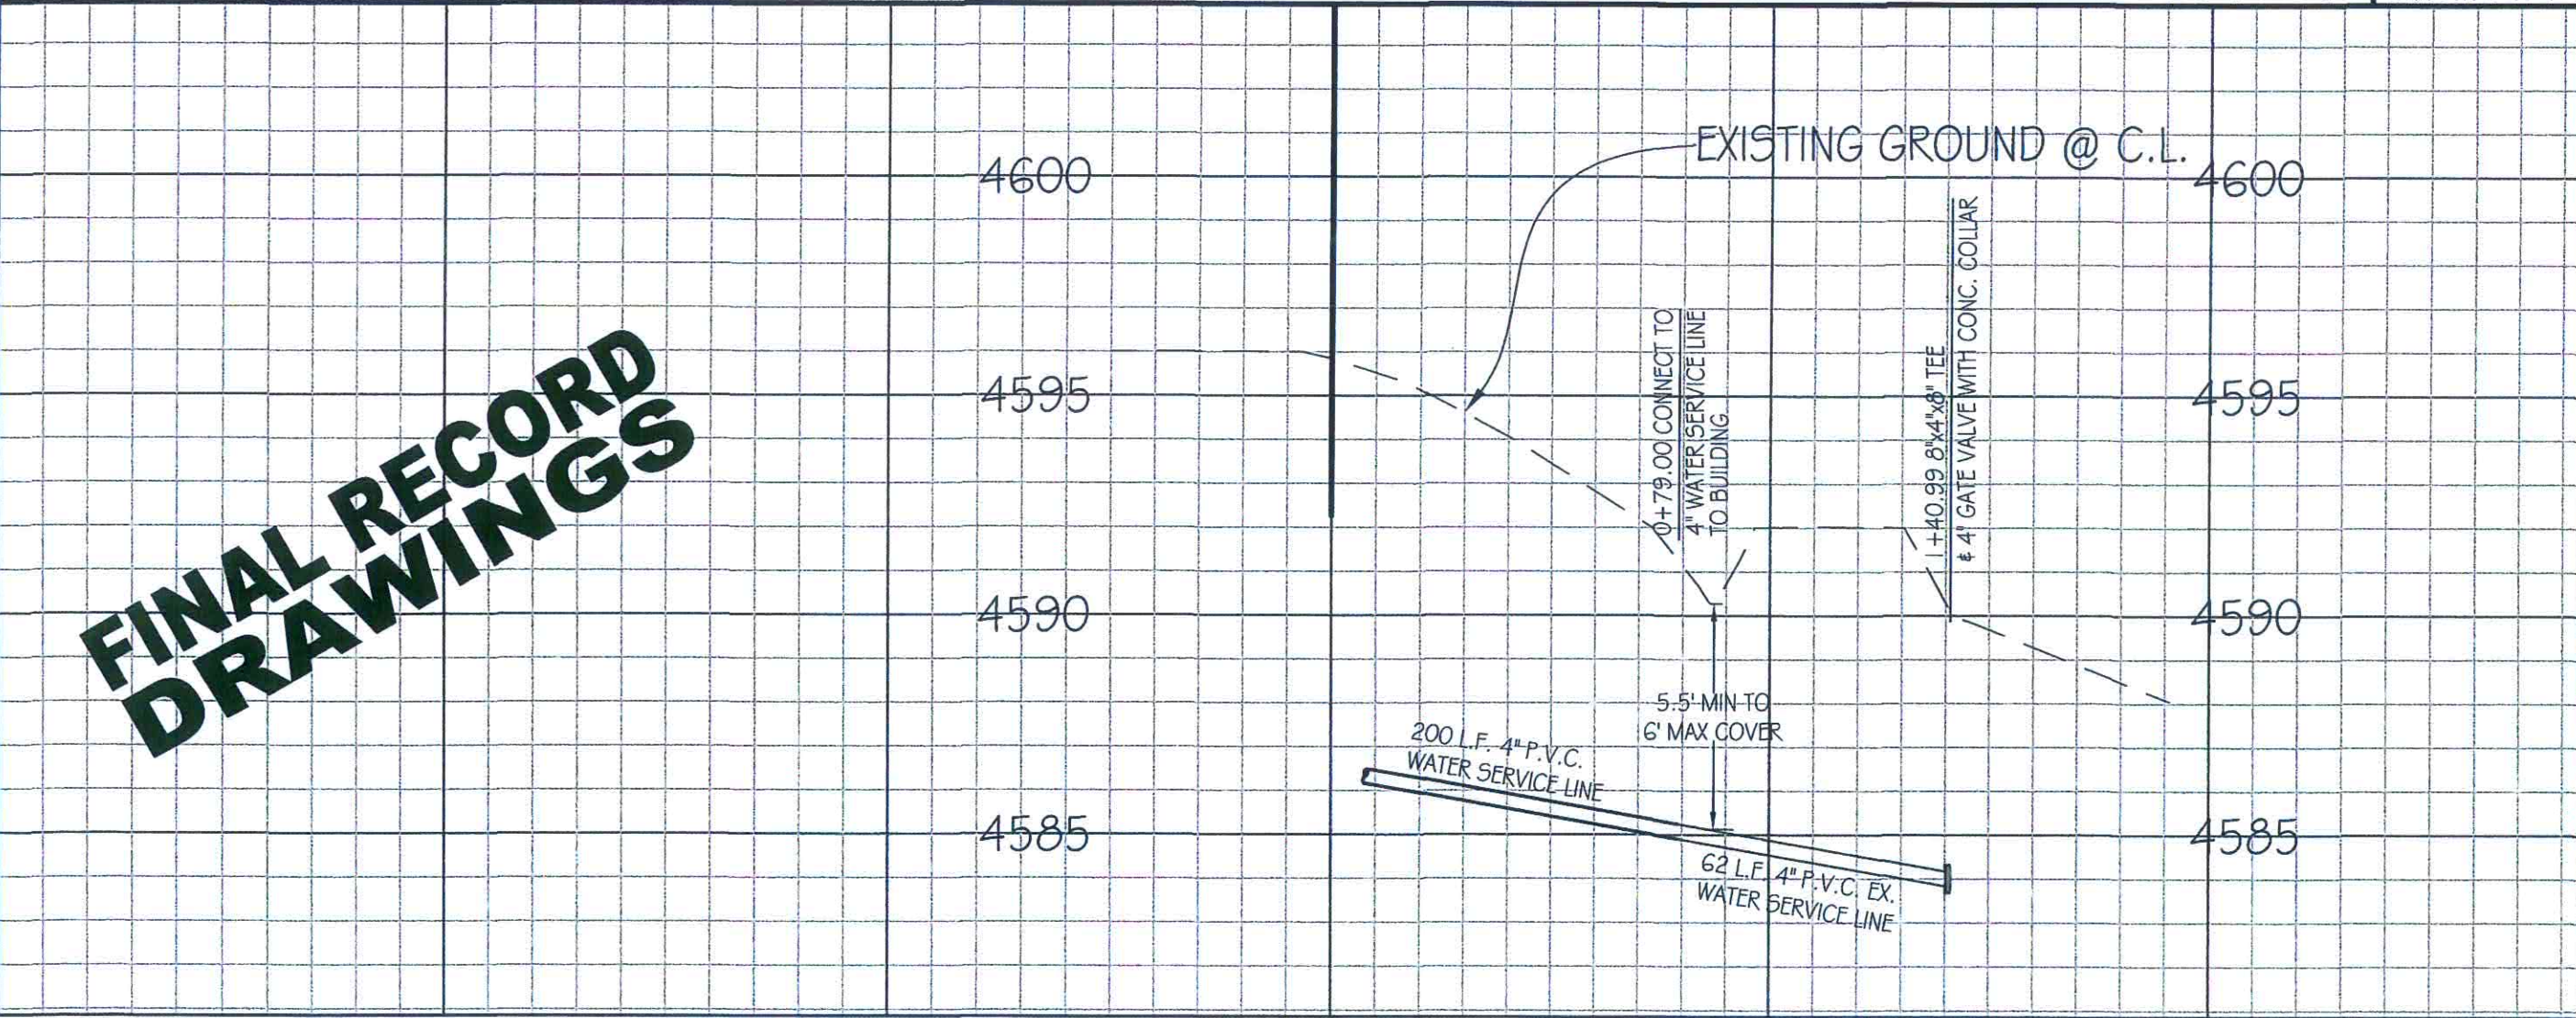

| REV. | REVISION DESCRIPTION | DATE | BY |
|------|----------------------|------|----|
|      |                      |      |    |
|      |                      |      |    |
**PAT'S OFFROAD  
IMPROVMENT PLANS  
WATER PLAN & PROFILE**

**CAROL CHADWICK, P.E.**  
*Carol Chadwick, P.E.*  
427 S.W. Wise Drive  
Lake City, FL 32024  
(907) 680-1772  
ccpewy@gmail.com  
WYOMING • MONTANA • NEVADA • IDAHO  
FLORIDA • OREGON • CALIFORNIA • N.C.E.E.S.

|              |          |
|--------------|----------|
| DATE:        | 08/10/17 |
| JOB NO:      | 16081    |
| DRAWN BY:    | CC       |
| APPROVED BY: | CC       |